



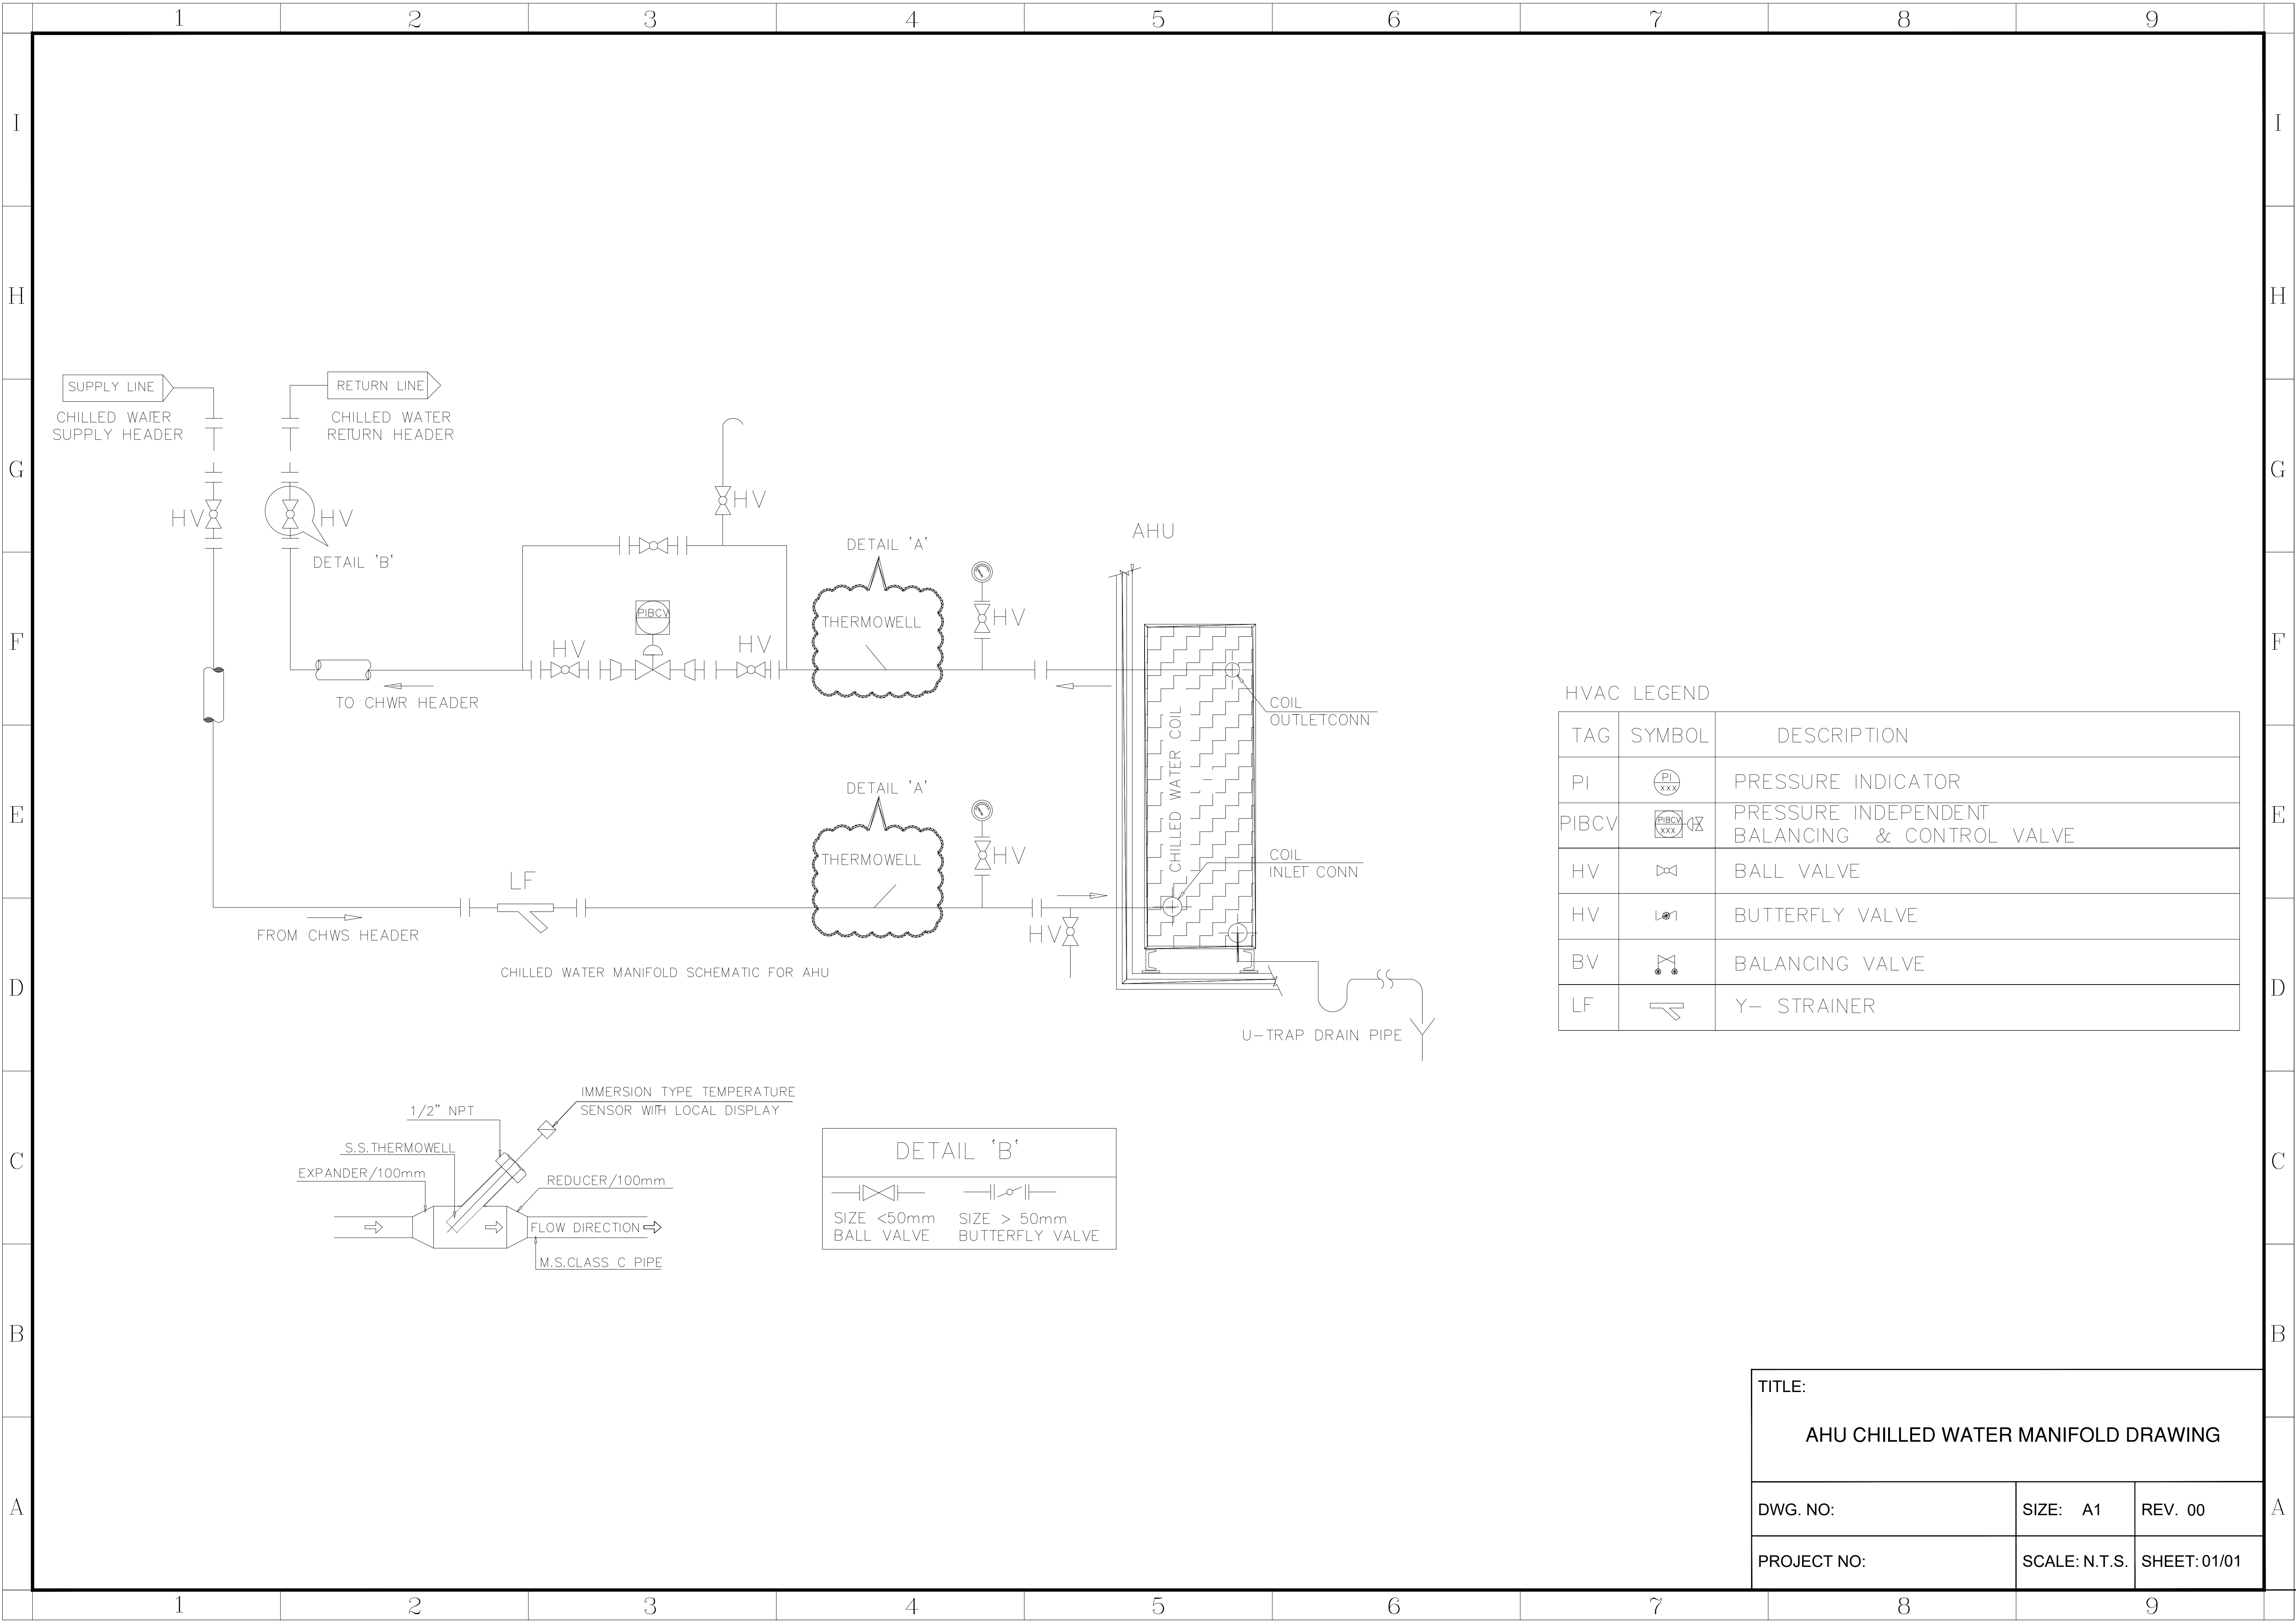

HVAC LEGEND

TAG	SYMBOL	DESCRIPTION
PI		PRESSURE INDICATOR
PIBCV		PRESSURE INDEPENDENT BALANCING & CONTROL VALVE
HV		BALL VALVE
HV		BUTTERFLY VALVE
BV		BALANCING VALVE
LF		Y- STRAINER

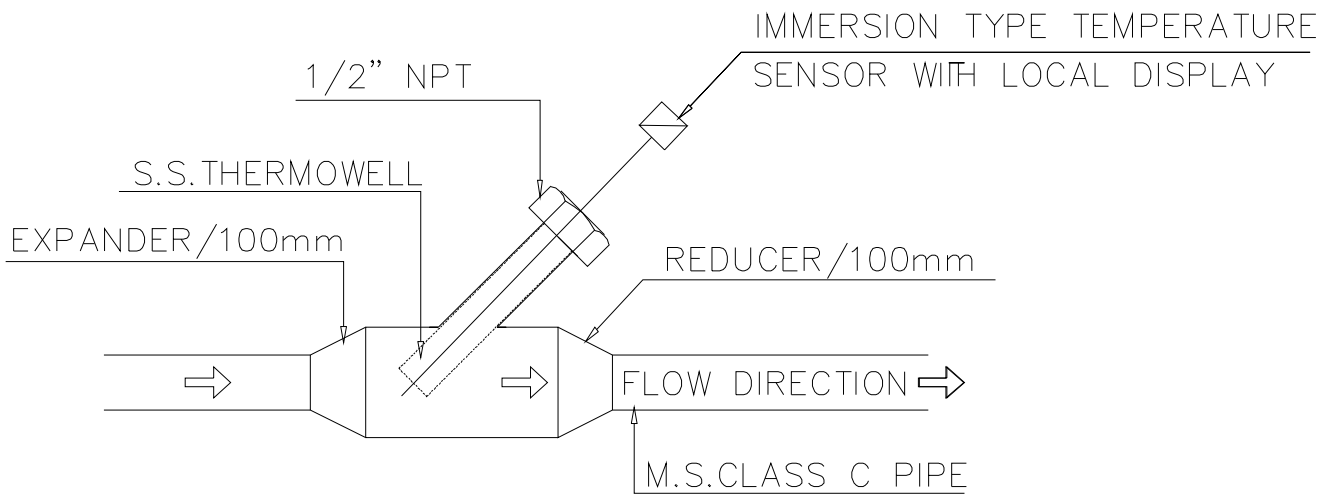

DETAIL 'B'	
SIZE <50mm BALL VALVE	SIZE > 50mm BUTTERFLY VALVE

TITLE:		
AHU CHILLED WATER MANIFOLD DRAWING		
DWG. NO:	SIZE: A1	REV. 00
PROJECT NO:	SCALE: N.T.S.	SHEET: 01/01